

**DECISION UNDER DELEGATED AUTHORITY ON AN APPLICATION
BY CHRISTCHURCH CASINOS LIMITED FOR APPROVAL OF
A NEW FLOOR PLAN FOR THE CHRISTCHURCH CASINO**

Date of Decision: 18 February 2022

1. On 16 February 2022, Christchurch Casinos Limited Limited (“CCL”) applied, pursuant to condition 12 of its operator’s licence, for approval of a new floor plan, “Level 2 Gallery Changes – Bank 40 Update – February 2022”.
2. Condition 12 of CCL’s operator’s licence provides as follows:
 12. The Licence Holder shall obtain the approval of the Commission for new floor plans prior to relocating or installing tables or machines in positions not specified in approved floor layouts. When applying the Licence Holder must submit fresh plans showing the floor layout for the Gambling Area and details of the proposed CCTV layout for the consideration of the Commission. Any change must comply with the Surveillance Standard. The Executive Director and a single Gambling Commissioner may approve the new floor plans if they are satisfied that the floor layout has no potentially adverse effects. If they are not so satisfied, the proposed floor plan must be referred to the Commission for a decision on approval.
3. CCL submitted:
 - It wants to make temporary changes to its Level 2 Gallery Floor Plan while in the red setting of the CPF.
 - As it transitions to open the Gallery Window, it wants to create better spacing, flow and visibility for customers on Bank 40, which is at the entrance to the Level 2 Gallery EGM area.
 - It wants to reduce a 6 EGM bank to a 4 EGM Carousel bank for Bank 40.
4. The proposed floor plan raises no issues of regulatory concern for the Commission. Accordingly plan “Level 2 Gallery Changes – Bank 40 Update – February 2022” is approved by the Chief Gambling Commissioner and the Executive Director under delegated authority pursuant to condition 12 of CCL’s operator’s licence for the Christchurch casino. The floor plan is **attached**.




Lisa Hansen
Chief Gambling Commissioner
Gambling Commission



Blair Cairncross
Executive Director
Gambling Commission

18 February 2022



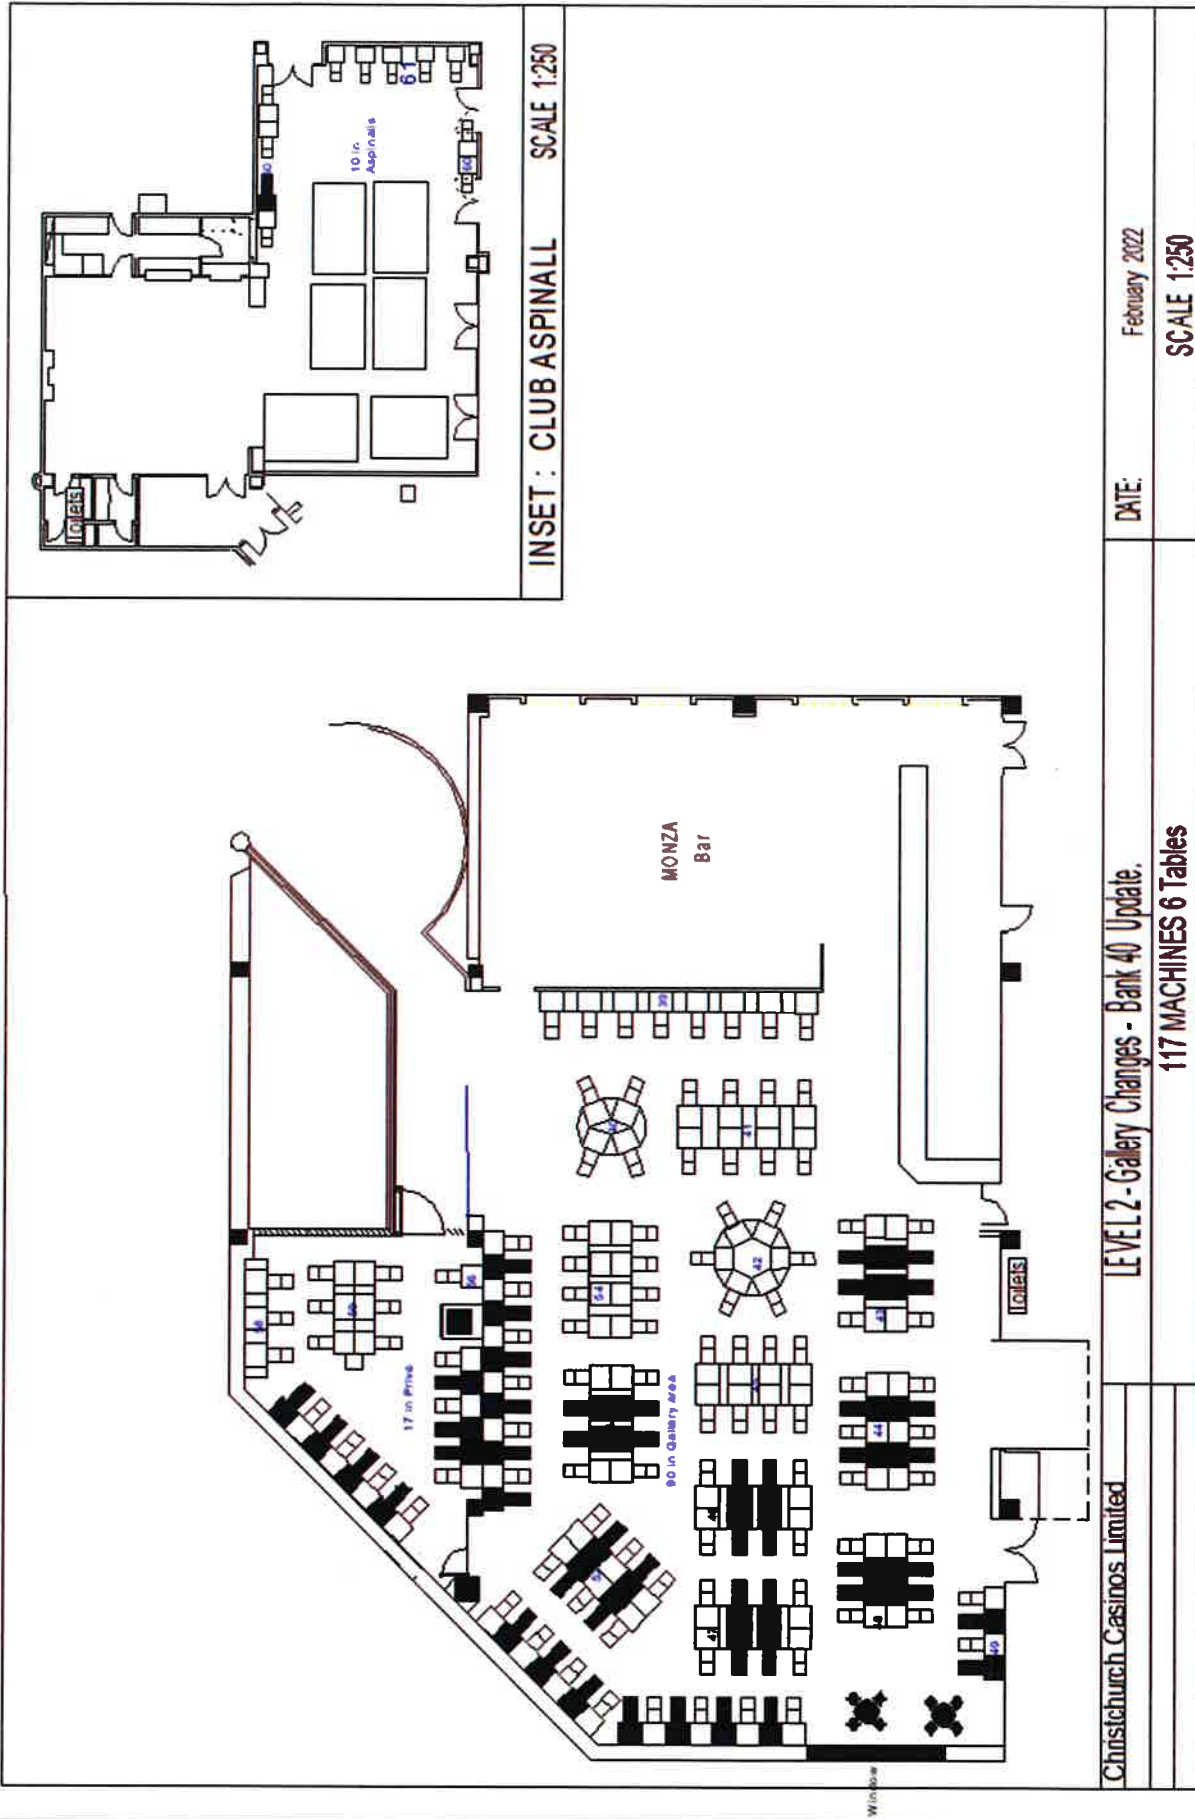

Christchurch Casinos Limited

LEVEL 2 - Gallery Changes - Bank 40 Update.
117 MACHINES 6 Tables

DATE: February 2022
SCALE 1:250