

**DECISION UNDER DELEGATED AUTHORITY ON AN APPLICATION  
BY CHRISTCHURCH CASINOS LIMITED FOR APPROVAL OF  
A NEW FLOOR PLAN FOR LEVEL 1 OF THE CHRISTCHURCH CASINO**

**Date of Decision:** 15 November 2016

1. On 27 October 2016, Christchurch Casinos Limited ("CCL") applied, pursuant to condition 12 of its operator's licence, for approval of a new floor plan, 2016 L1 001, for Level 1 of the Christchurch casino.
2. Condition 12 provides as follows:

The Licence Holder shall obtain the approval of the Commission for new floor plans prior to relocating or installing tables or machines in positions not specified in approved floor layouts. When applying the Licence Holder must submit fresh plans showing the floor layout for the Gambling Area and details of the proposed CCTV layout for the consideration of the Commission. Any change must comply with the Surveillance Standard. The Executive Director and a single Gambling Commissioner may approve the new floor plans if they are satisfied that the floor layout has no potentially adverse effects. If they are not so satisfied, the proposed floor plan must be referred to the Commission for a decision on approval.
3. CCL submitted that:
  - (a) It wants to place Poker tables into the space vacated by the three offices on Level 1, to create a space specifically for them. The space is already designated as Gambling Area.
  - (b) It wants to commence work in mid-January 2017.
4. The proposal raises no issues of regulatory concern for the Commission. Accordingly new plan 2016 L1 001 (**attached**), is approved by the Chief Gambling Commissioner and the Executive Director under delegated authority pursuant to condition 12 of CCL's operator's licence for the Christchurch casino.
5. Historically, the Gambling Area levels at the casino have been referred to as Levels 3 and 4. In future to avoid confusion amongst customers, and for ease of reference, Level 3 will be referred to as Level 1 and Level 4 as Level 2. In the future, floor plan numbers will reflect this.
6. The plan for Level 2, previously approved as Level 4 in April 2016, has now been renamed plan 2016 L2 001 and is also **attached**.



7. Once CCL is reliant on plan 2016 L1 001, plan "August 2015" will cease to be valid.




**Graeme Reeves**  
Chief Gambling Commissioner  
Gambling Commission

15<sup>th</sup> November 2016




**Nick Paterson**  
Executive Director  
Gambling Commission



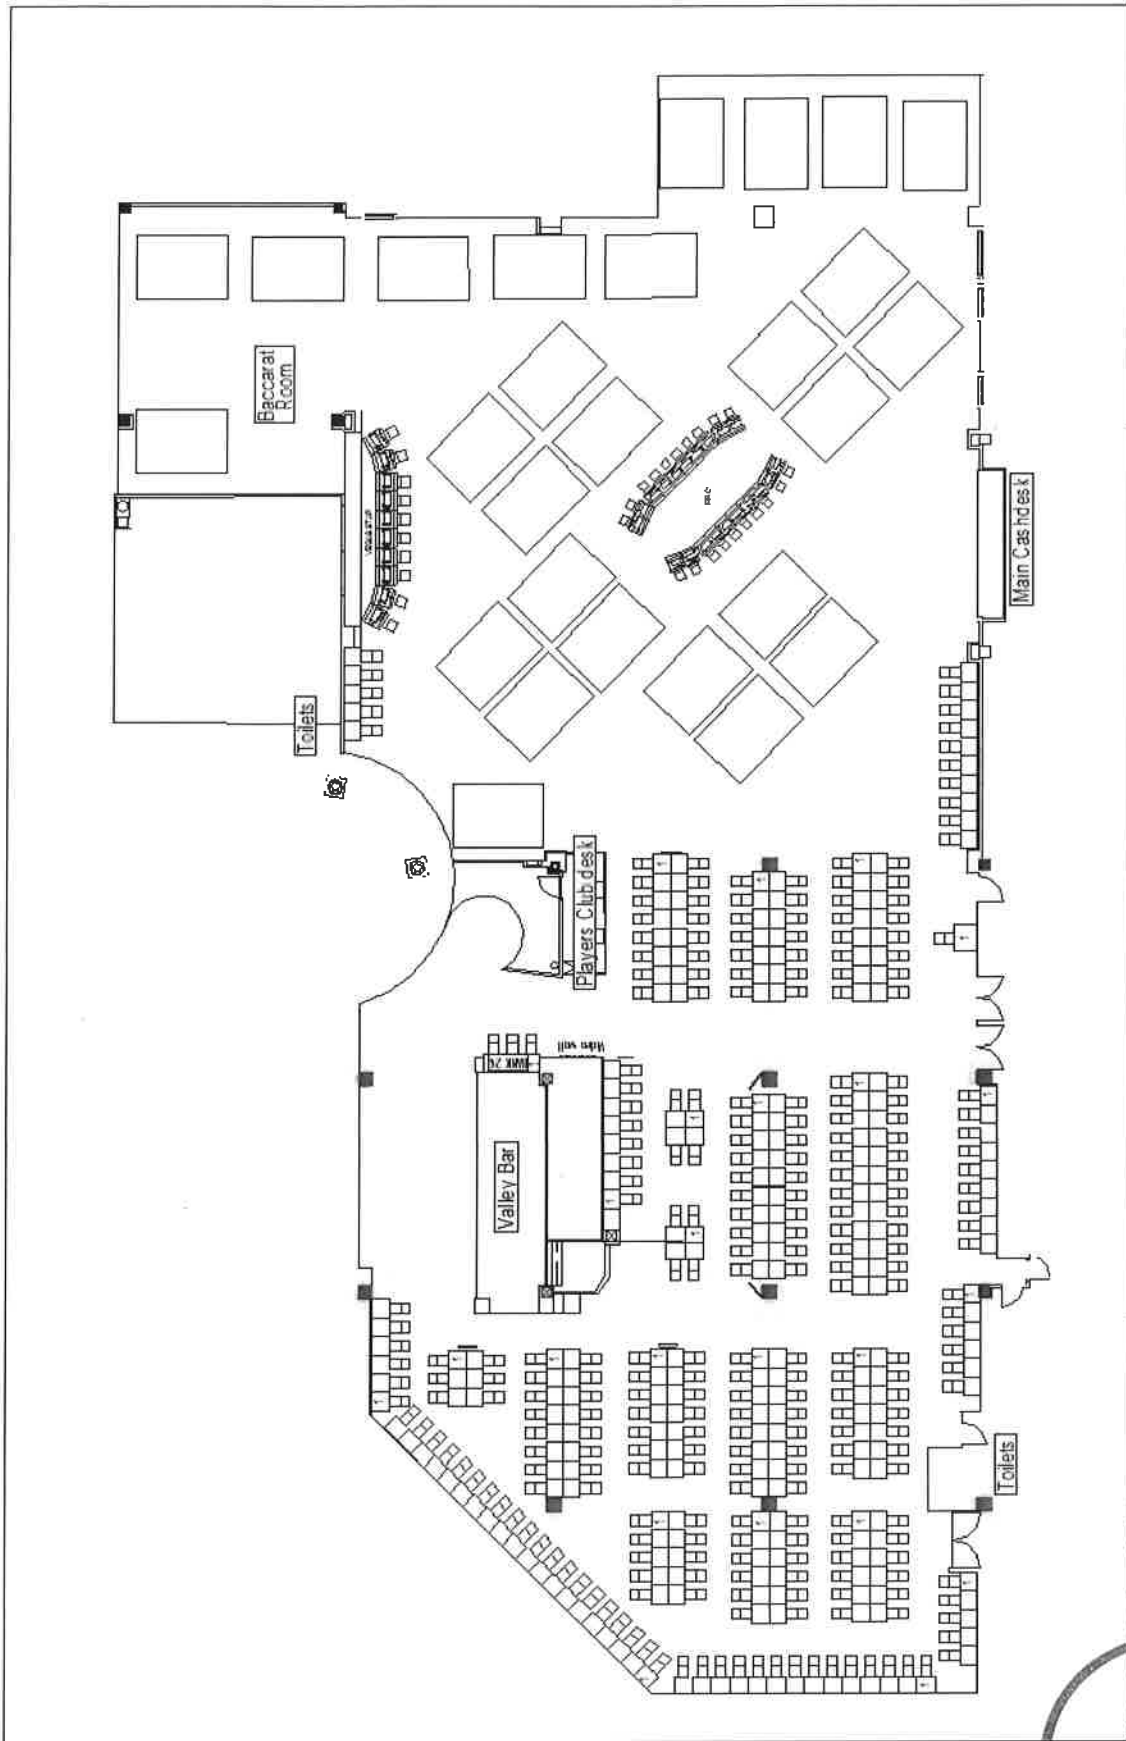

Christchurch Casinos Limited	LEVEL 1 - Floor plan	DATE: October 2016
	295 MACHINES, 28 TABLES	SCALE 1:250



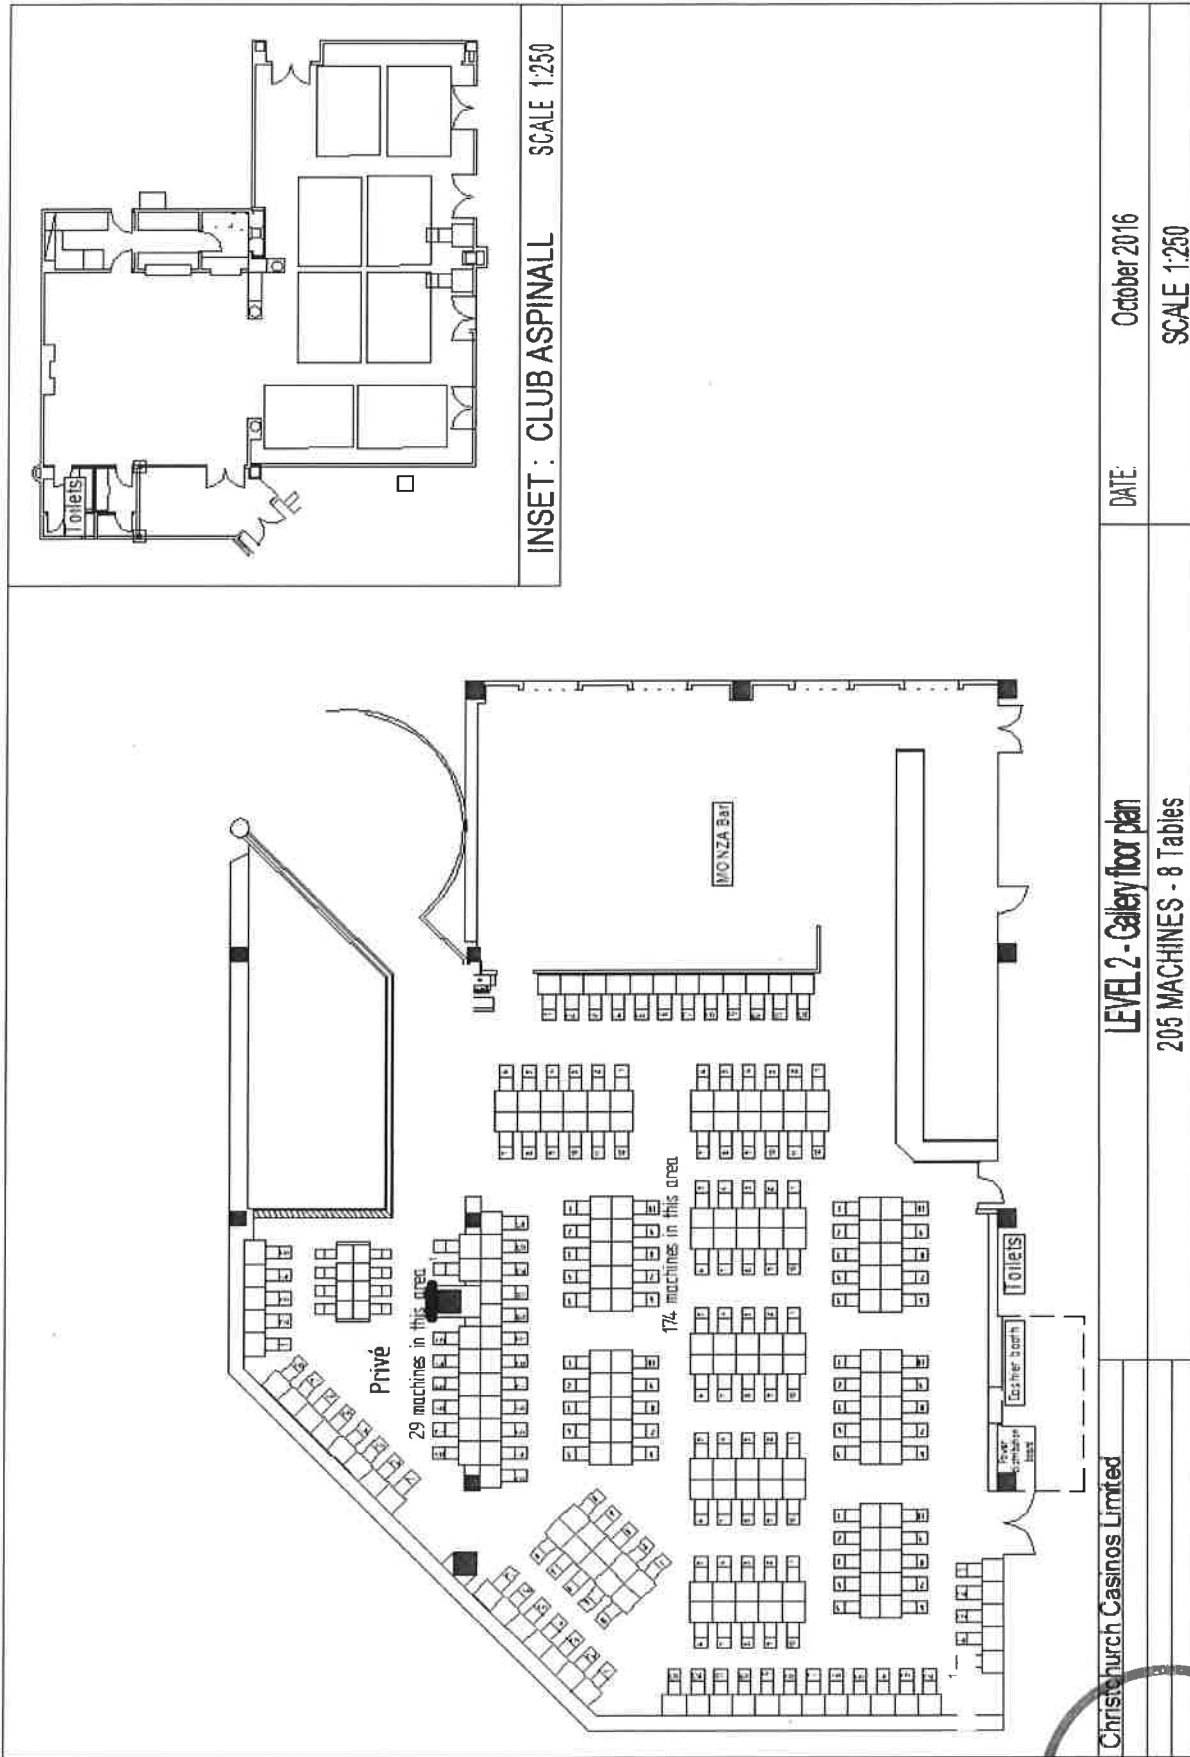

Christchurch Casinos Limited

LEVEL 2 - Gallery floor plan  
205 MACHINES - 8 Tables

DATE: October 2016  
SCALE 1:250

